


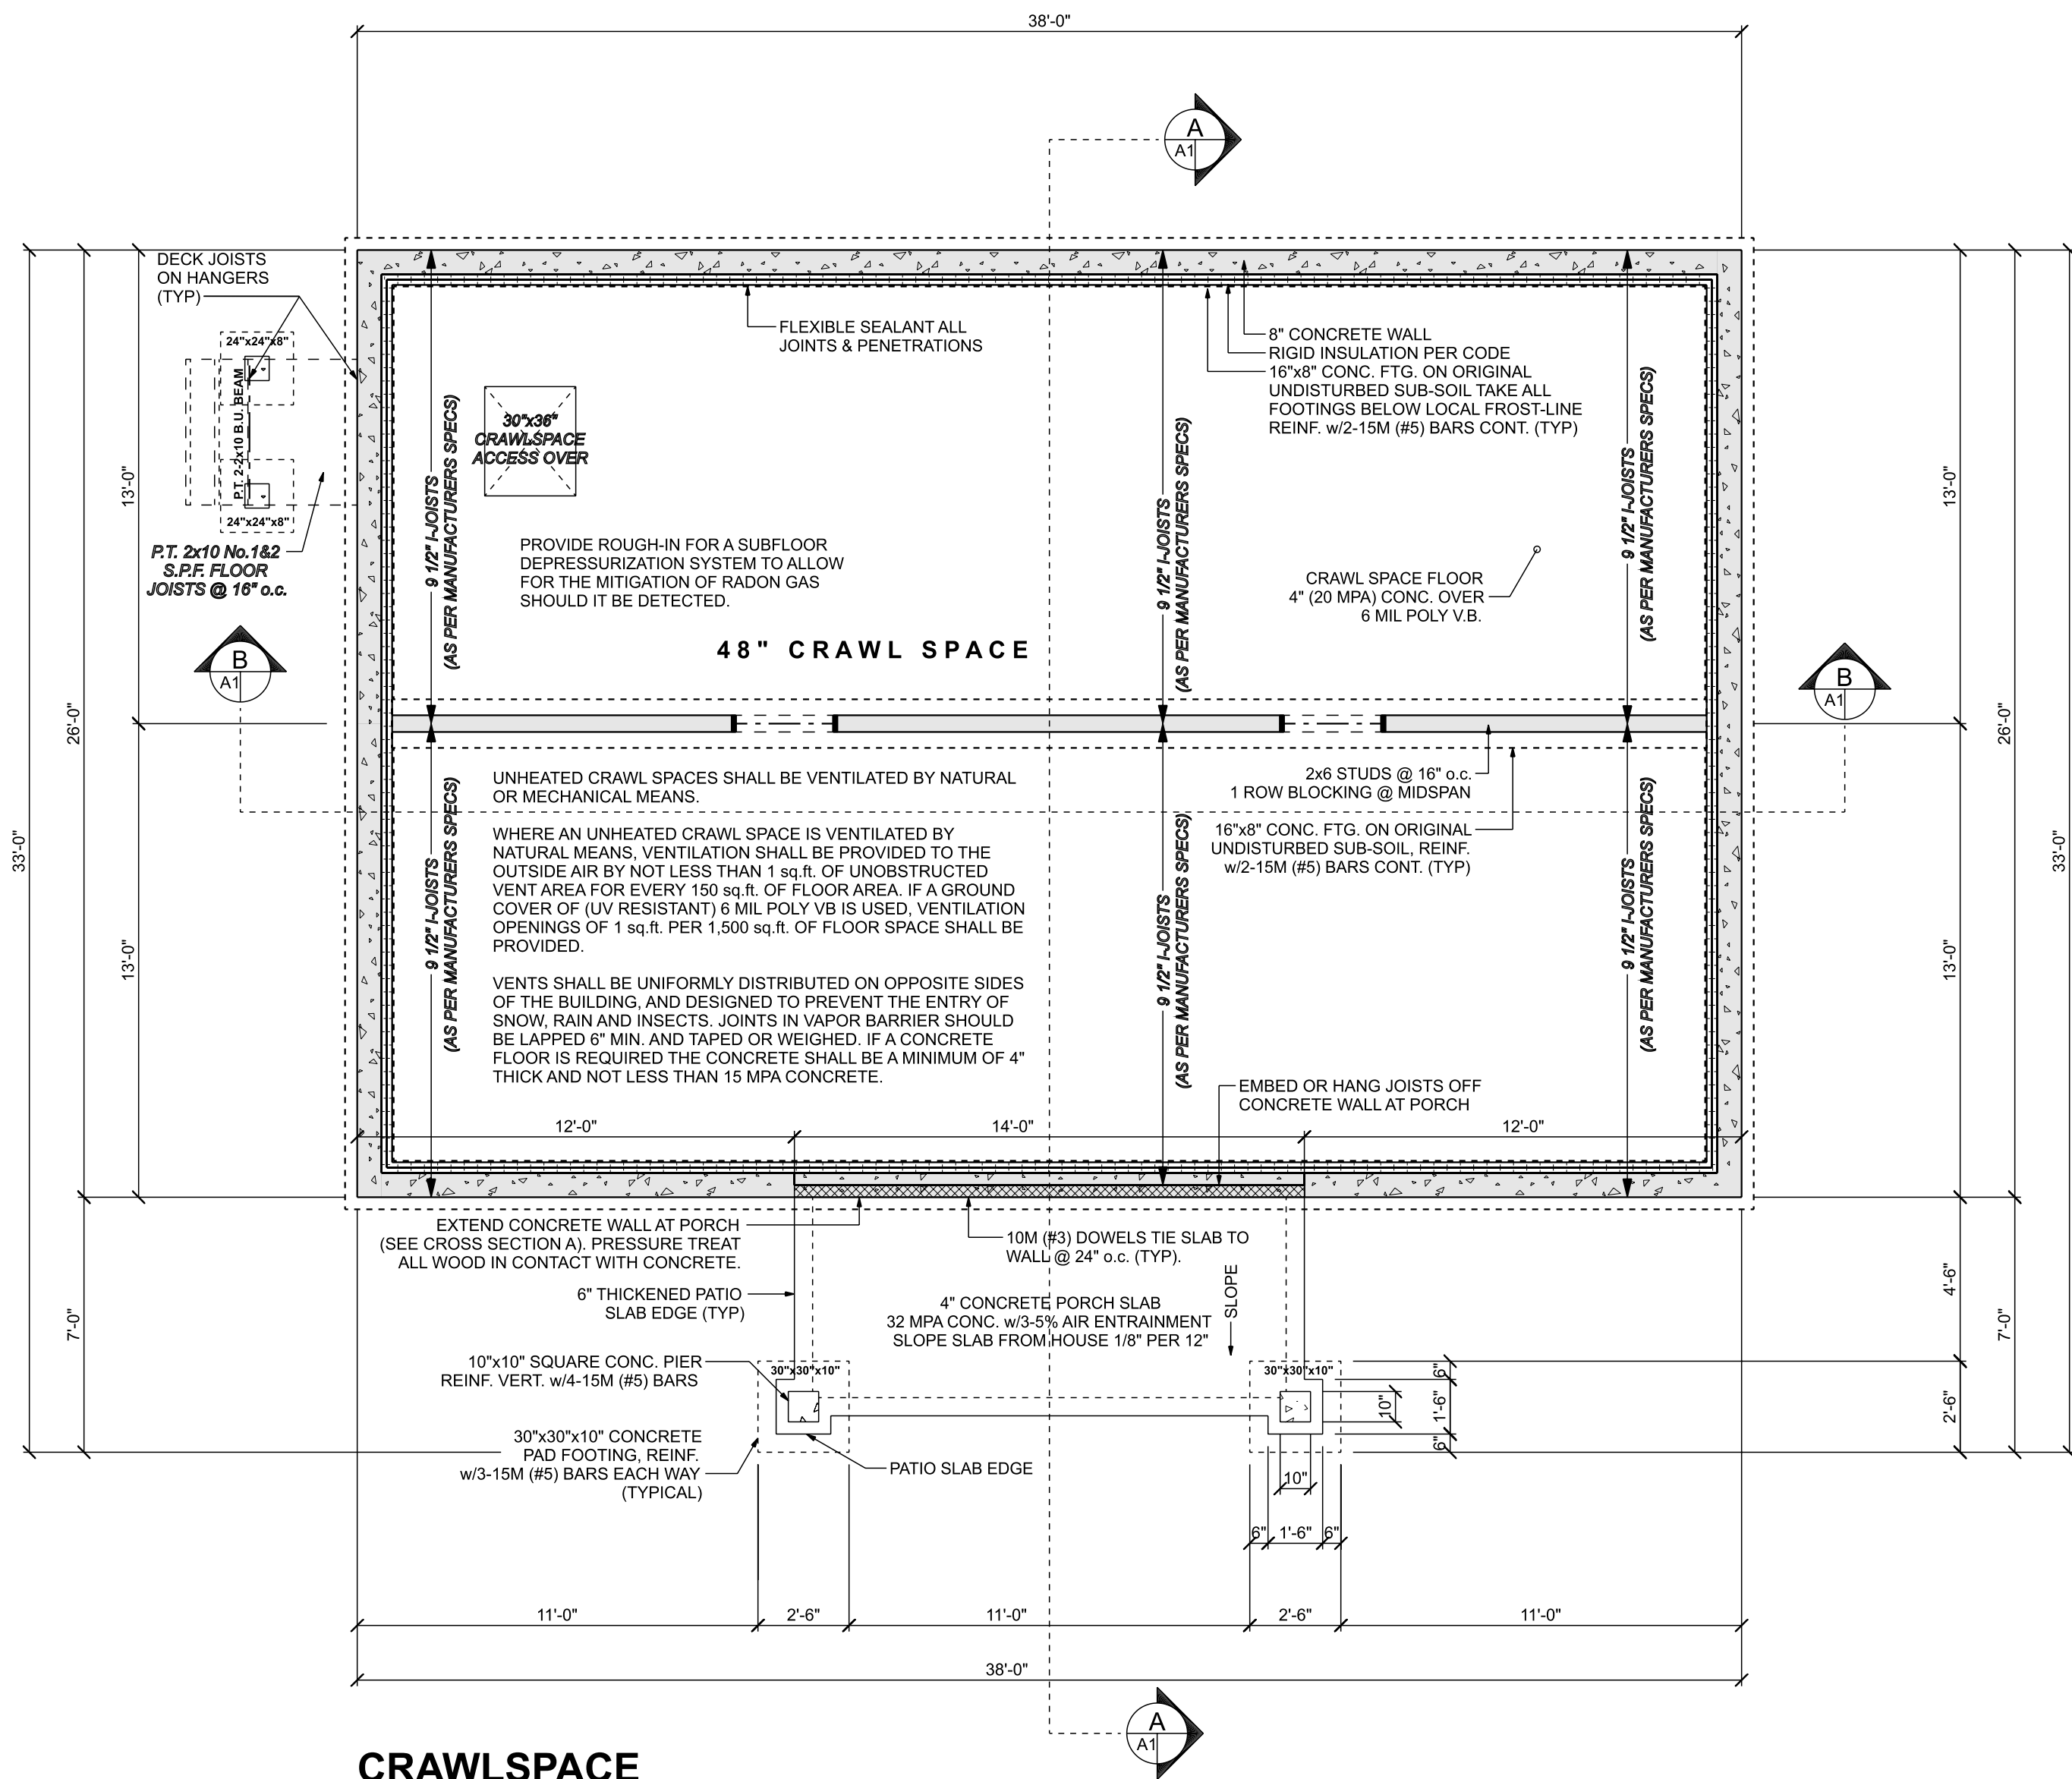


CRAWLSPACE FOUNDATION PLAN

SCALE: 1/4" = 1'-0"
CRAWLSPACE AREA: 988 sq.ft.

PLEASE READ CAREFULLY BEFORE BEGINING PROJECT:


-ALL FRAMING MATERIAL OTHER THAN STUDS SHALL BE NO. 1 & 2 S.P.F.
-ALL WORK IS TO BE DONE IN ACCORDANCE WITH A STUDS SHALL CONFORM TO THE LATEST EDITION OF THE B.C.B.C./I.R.C./U.B.C. (WHICHEVER TAKES PRECEDENCE IN THE AREA OF CONSTRUCTION) AND LOCAL CODES, BYLAWS AND REGULATIONS WHERE THESE TAKE PRECEDENCE.
-ALL WORK MUST BE DONE ACCORDING TO THE ACCEPTED PRACTICE OF THE DAY. THIS IS APPLICABLE TO THE GENERAL CONTRACTOR AND ALL SUB-TRADES. THE INTENT IS TO CONSTRUCT A SOUND, ADEQUATE BUILDING.
-ALL MATERIALS SHALL BE NEW AND THE BEST OF THEIR RESPECTIVE KIND UNLESS OTHERWISE SPECIFIED.
-ANYTHING NOT COVERED IN THE PLANS WILL BE OPEN FOR NEGOTIATION BETWEEN THE CONTRACTOR AND THE OWNER.
-WHILE EVERY ATTEMPT HAS BEEN MADE IN THE PREPARATION OF THIS PLAN TO AVOID MISTAKES, THE DESIGNER CANNOT GUARANTEE AGAINST HUMAN ERROR. THE CONTRACTOR OR BUILDER ON THE JOB MUST CHECK ALL DETAILS AND DIMENSIONS AND REPORT ANY DISCREPANCIES TO THE DESIGNER BEFORE ORDERING MATERIALS OR COMMENCING CONSTRUCTION.
-ALL SITE DIMENSIONS AND MEASUREMENTS ARE TO BE GOVERNED AND APPROVED BY MUNICIPAL AUTHORITIES BEFORE STARTING CONSTRUCTION.

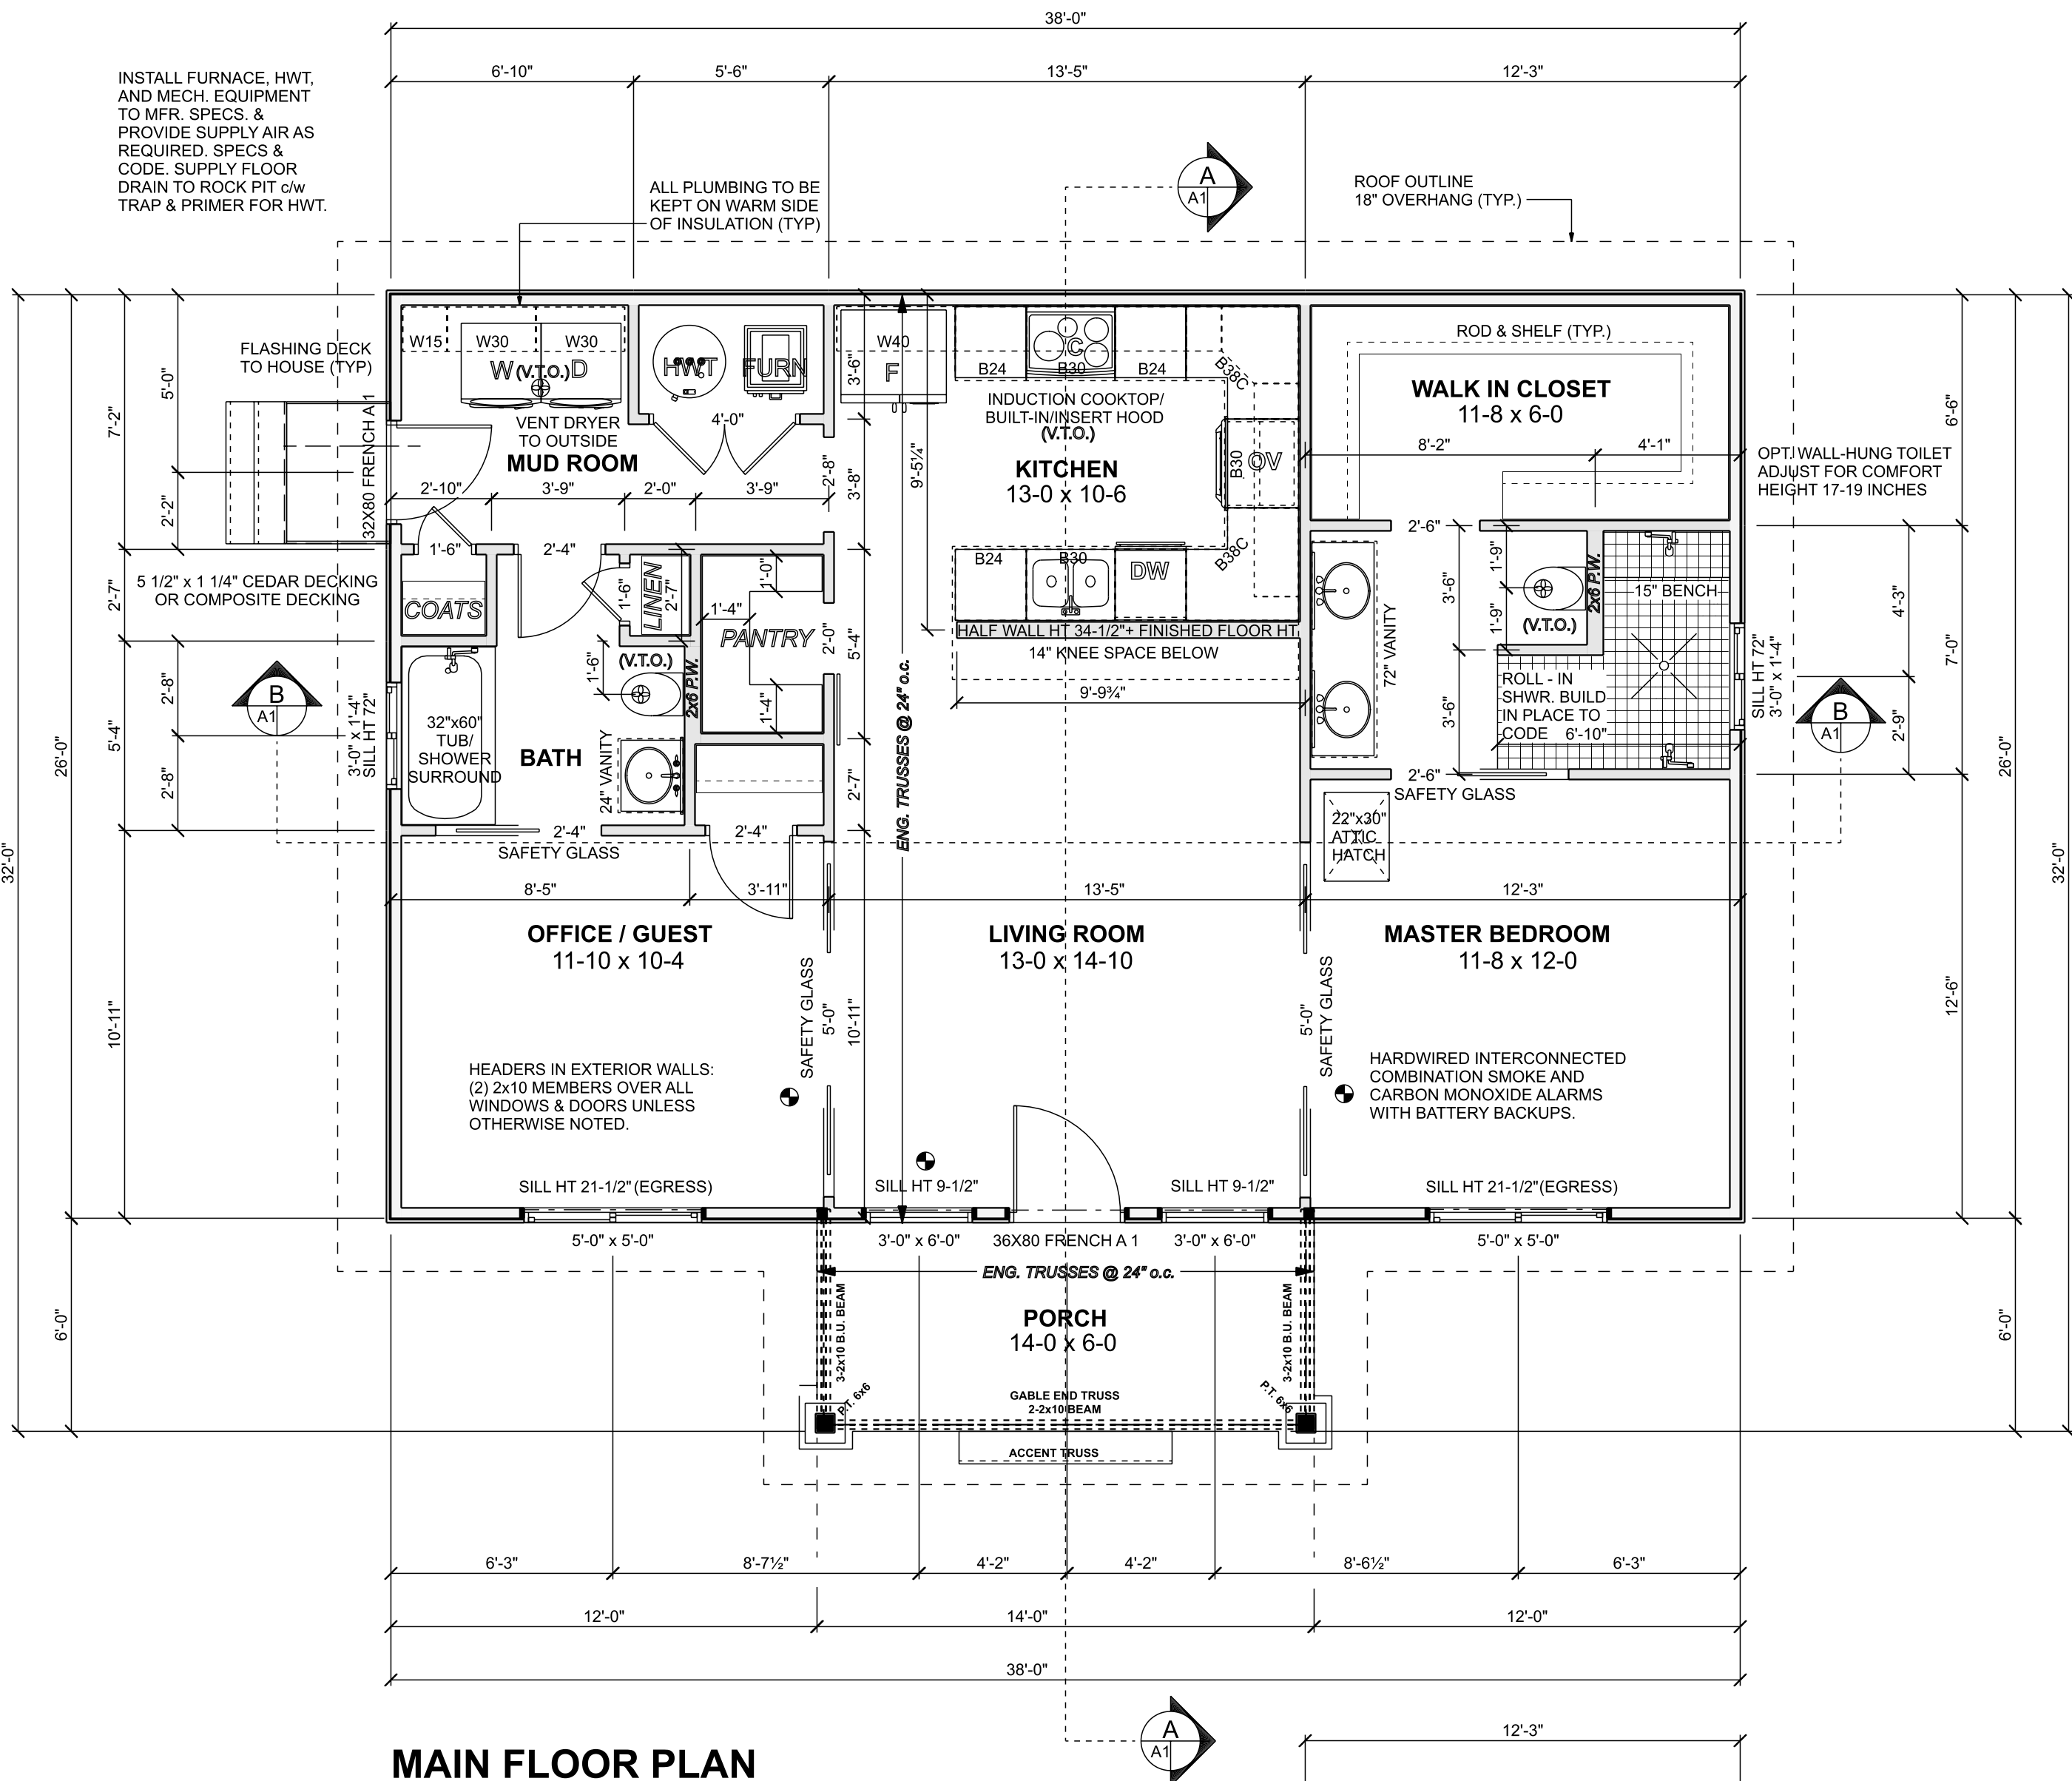

MAIN FLOOR PLAN

SCALE: 1/4" = 1'-0"
LIVING AREA: 988 sq.ft.

OPENING SCHEDULE									
PRODUCT CODE	COUNT	SIZE	R.O. WIDTH	R.O. HEIGHT	TEMPERED GLASS	EGRESS	GRILLE	SCREEN	
32X80 FRENCH A 1	1	2'-8"	2'-11"	6'-9 1/2"	Yes	Yes	Yes	No	
36X80 FRENCH A 1	1	3'-0"	3'-3"	6'-9 1/2"	Yes	Yes	Yes	No	
36X72 CASEMENT 1	2	3'-0" x 6'-0"	3'-0"	6'-0"	Yes	No	Yes	No	
36X16 SLIDER	2	3'-0" x 1'-4"	3'-0"	1'-4"	No	No	No	Yes	
60X60 SLIDER	2	5'-0" x 5'-0"	5'-0"	5'-0"	No	Yes	Yes	Yes	

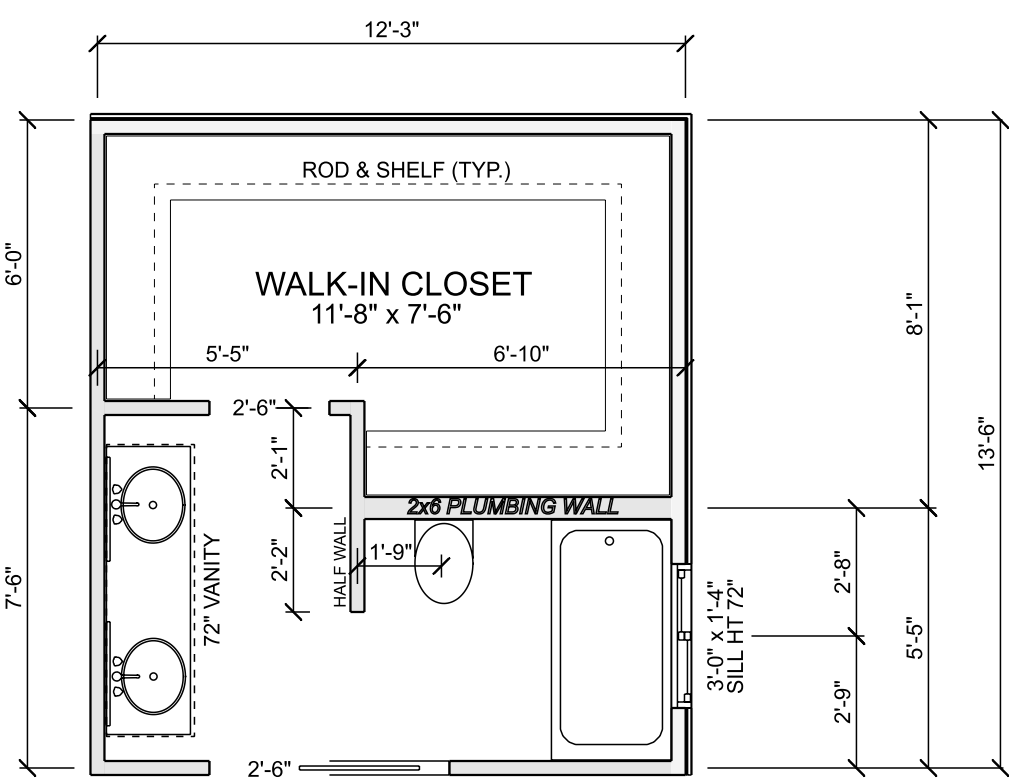


ALTERNATE MASTER BATH LAYOUT

COPYRIGHTED DOCUMENTS ILLEGAL TO REPRODUCE

THESE PLANS ARE THE COPYRIGHTED PROPERTY OF WESPLAN BUILDING DESIGN INC. AND HAVE BEEN LICENSED TO THE ORIGINAL PURCHASER FOR THE CONSTRUCTION OF ONE BUILDING. IT IS UNLAWFUL TO REPRODUCE THESE DOCUMENTS WITHOUT WRITTEN PERMISSION IN THE FORM OF A LICENSE AGREEMENT.

Foundation Plan & Floor Plan

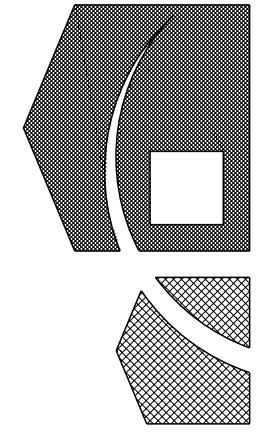

Wesplan Building Design Inc.
Your Number One Source for Home Plans Since 1950
Telephone: 800.361.5526
e-mail: am@westhomeplanners.com
web: www.westhomeplanners.com

PLAN NO.
580988

CRAWLSPACE


SHEET NO.
A1

DESIGN BY: ANMMAG DATE: 1/16/2024
DRAWN BY: ANMMAG REVISED:


© Wesplan Building Design Inc. All Rights Reserved
Reproduction of these drawings, in whole or in part, including any direct copying and/or preparation of derivative works thereof, for any reason without prior written permission of Wesplan Building Design Inc. is strictly prohibited. The buyer agrees to indemnify and hold the designer harmless from and against all claims, damages, costs and expenses, including reasonable attorney's fees, which may be incurred by the designer as a result of the buyer's use of these drawings. The buyer agrees to use the drawings for the construction of the building only and not for any other purpose. The buyer agrees to return the drawings to the designer at a reduced price from the original set or as part of a multiple set package does not entitle the buyer with license to construct more than one dwelling unit.

Due to local codes, regulations and building practices, prior to because of specific conditions, these drawings may not be suitable or legal for use in the construction of a building in all localities. Consequently, these drawings are not to be used in any jurisdiction where they are not specifically intended for use and until the drawings have been brought into conformity with all local requirements. Additionally, Wesplan Building Design Inc. is unable to accept any responsibility for the construction of a building which does not conform to the original purchase price. Therefore, the holder must carefully inspect all dimensions and details in these drawings and assume responsibility for the same.


www.westhomeplanners.com

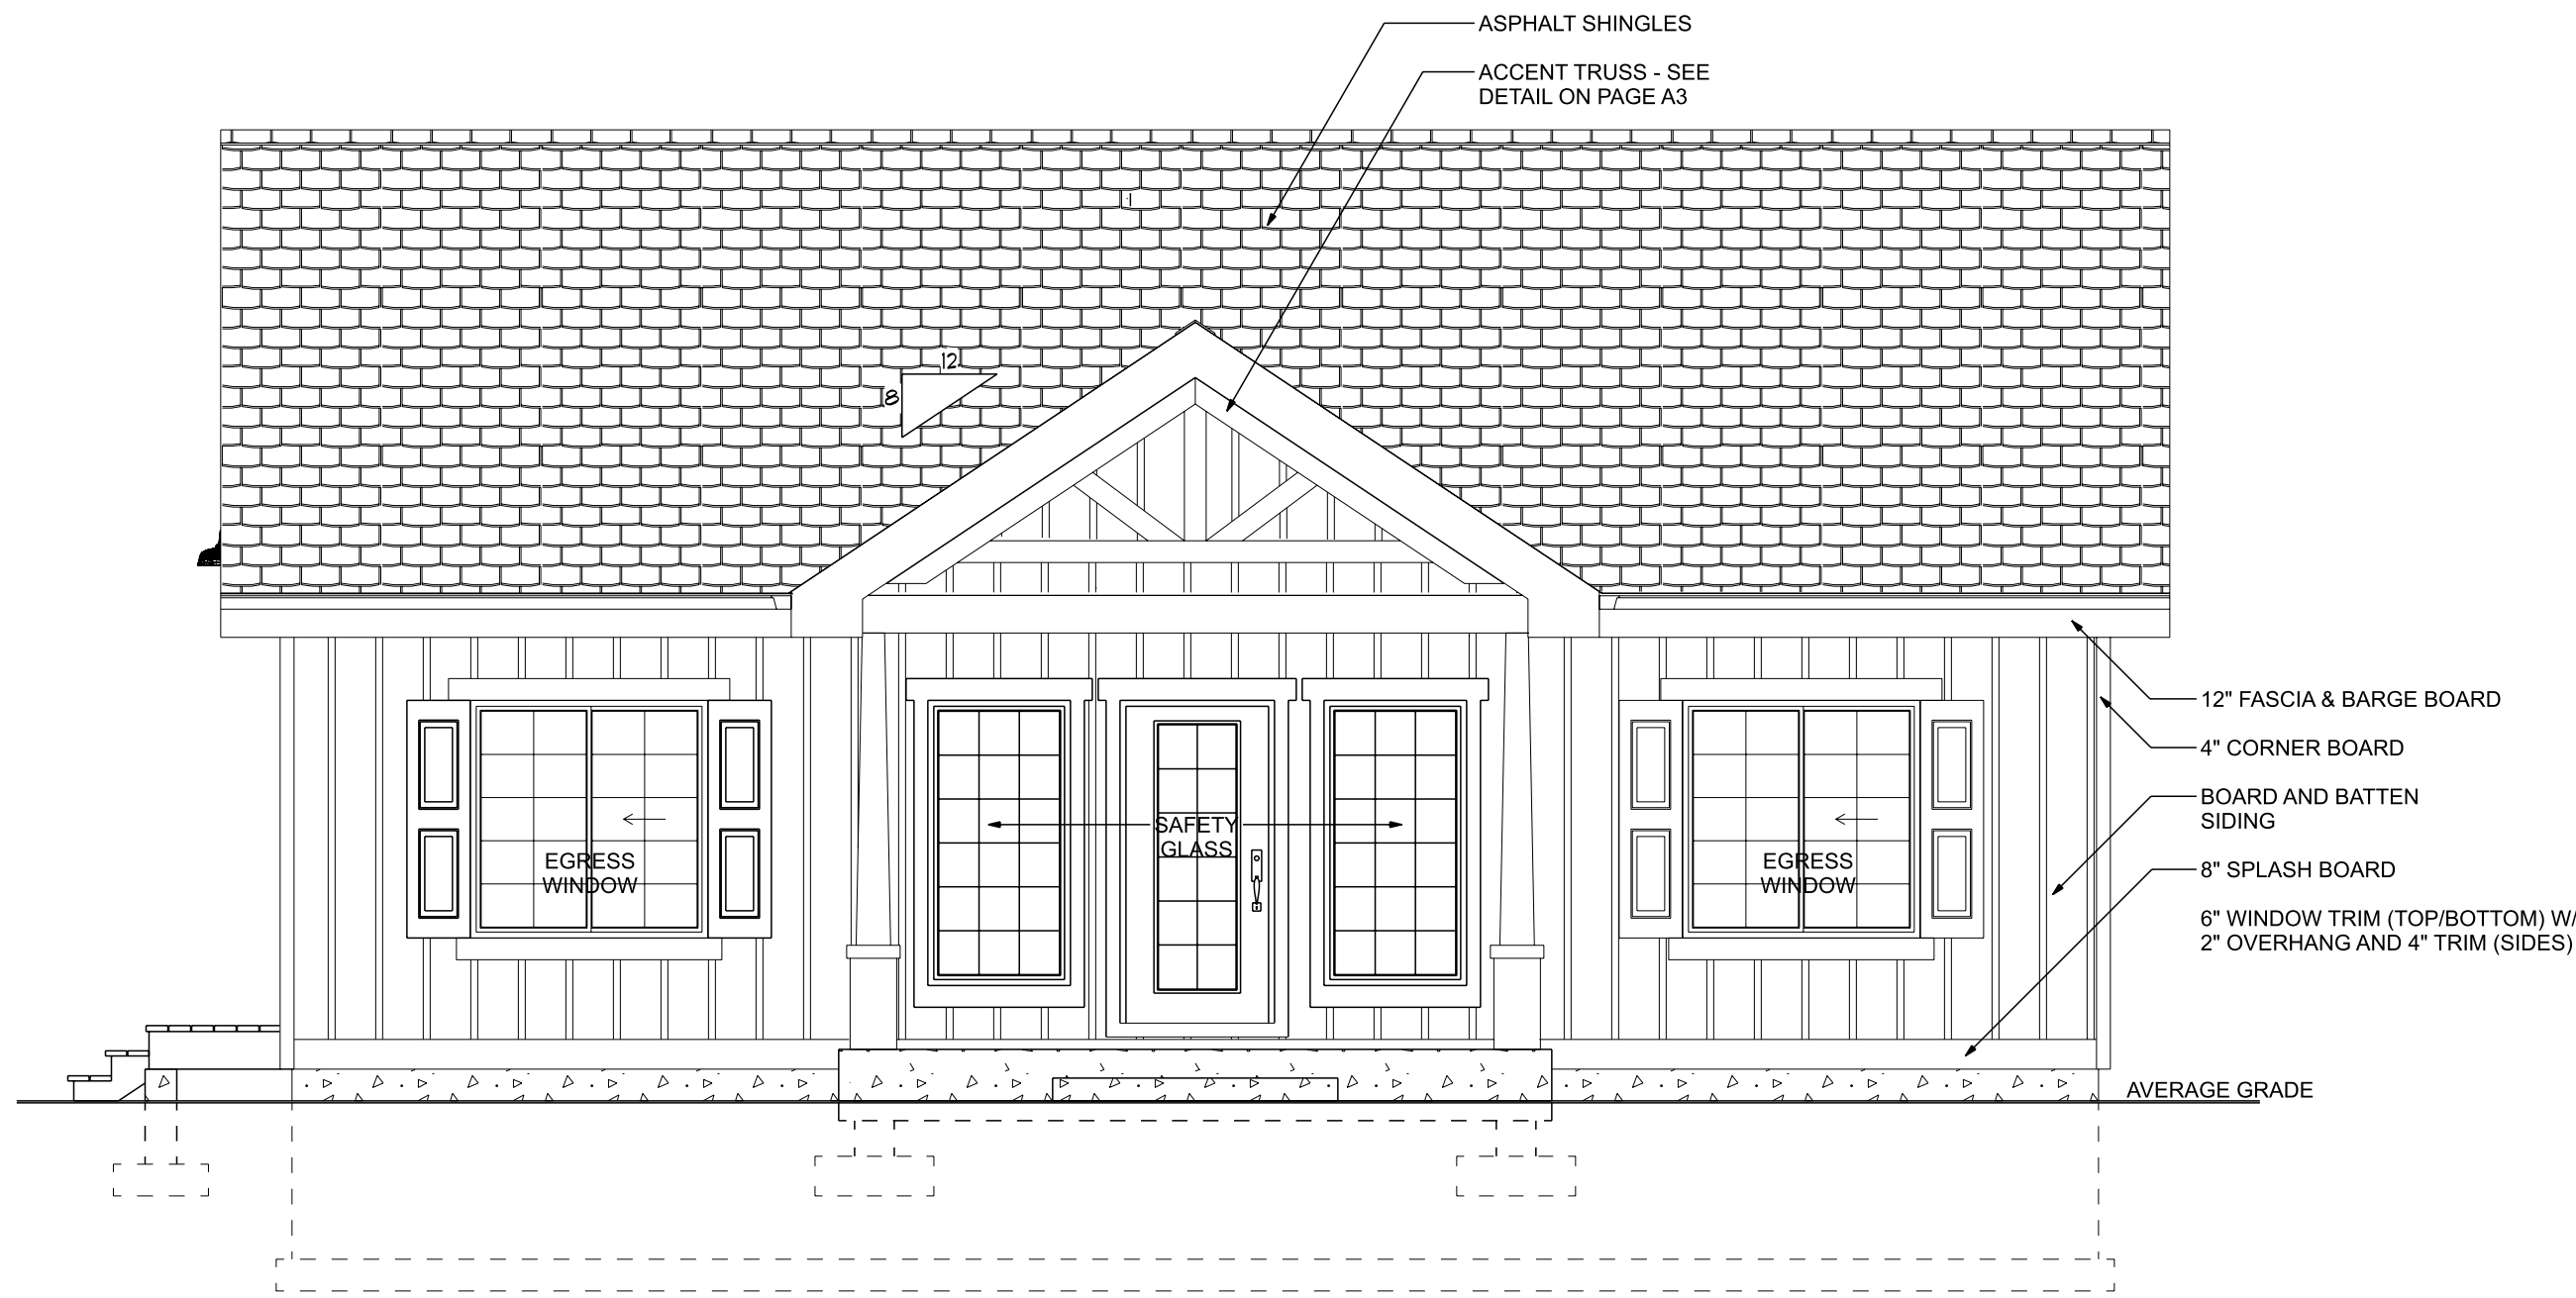


FRONT ELEVATION
SCALE: 1/4" = 1'-0"

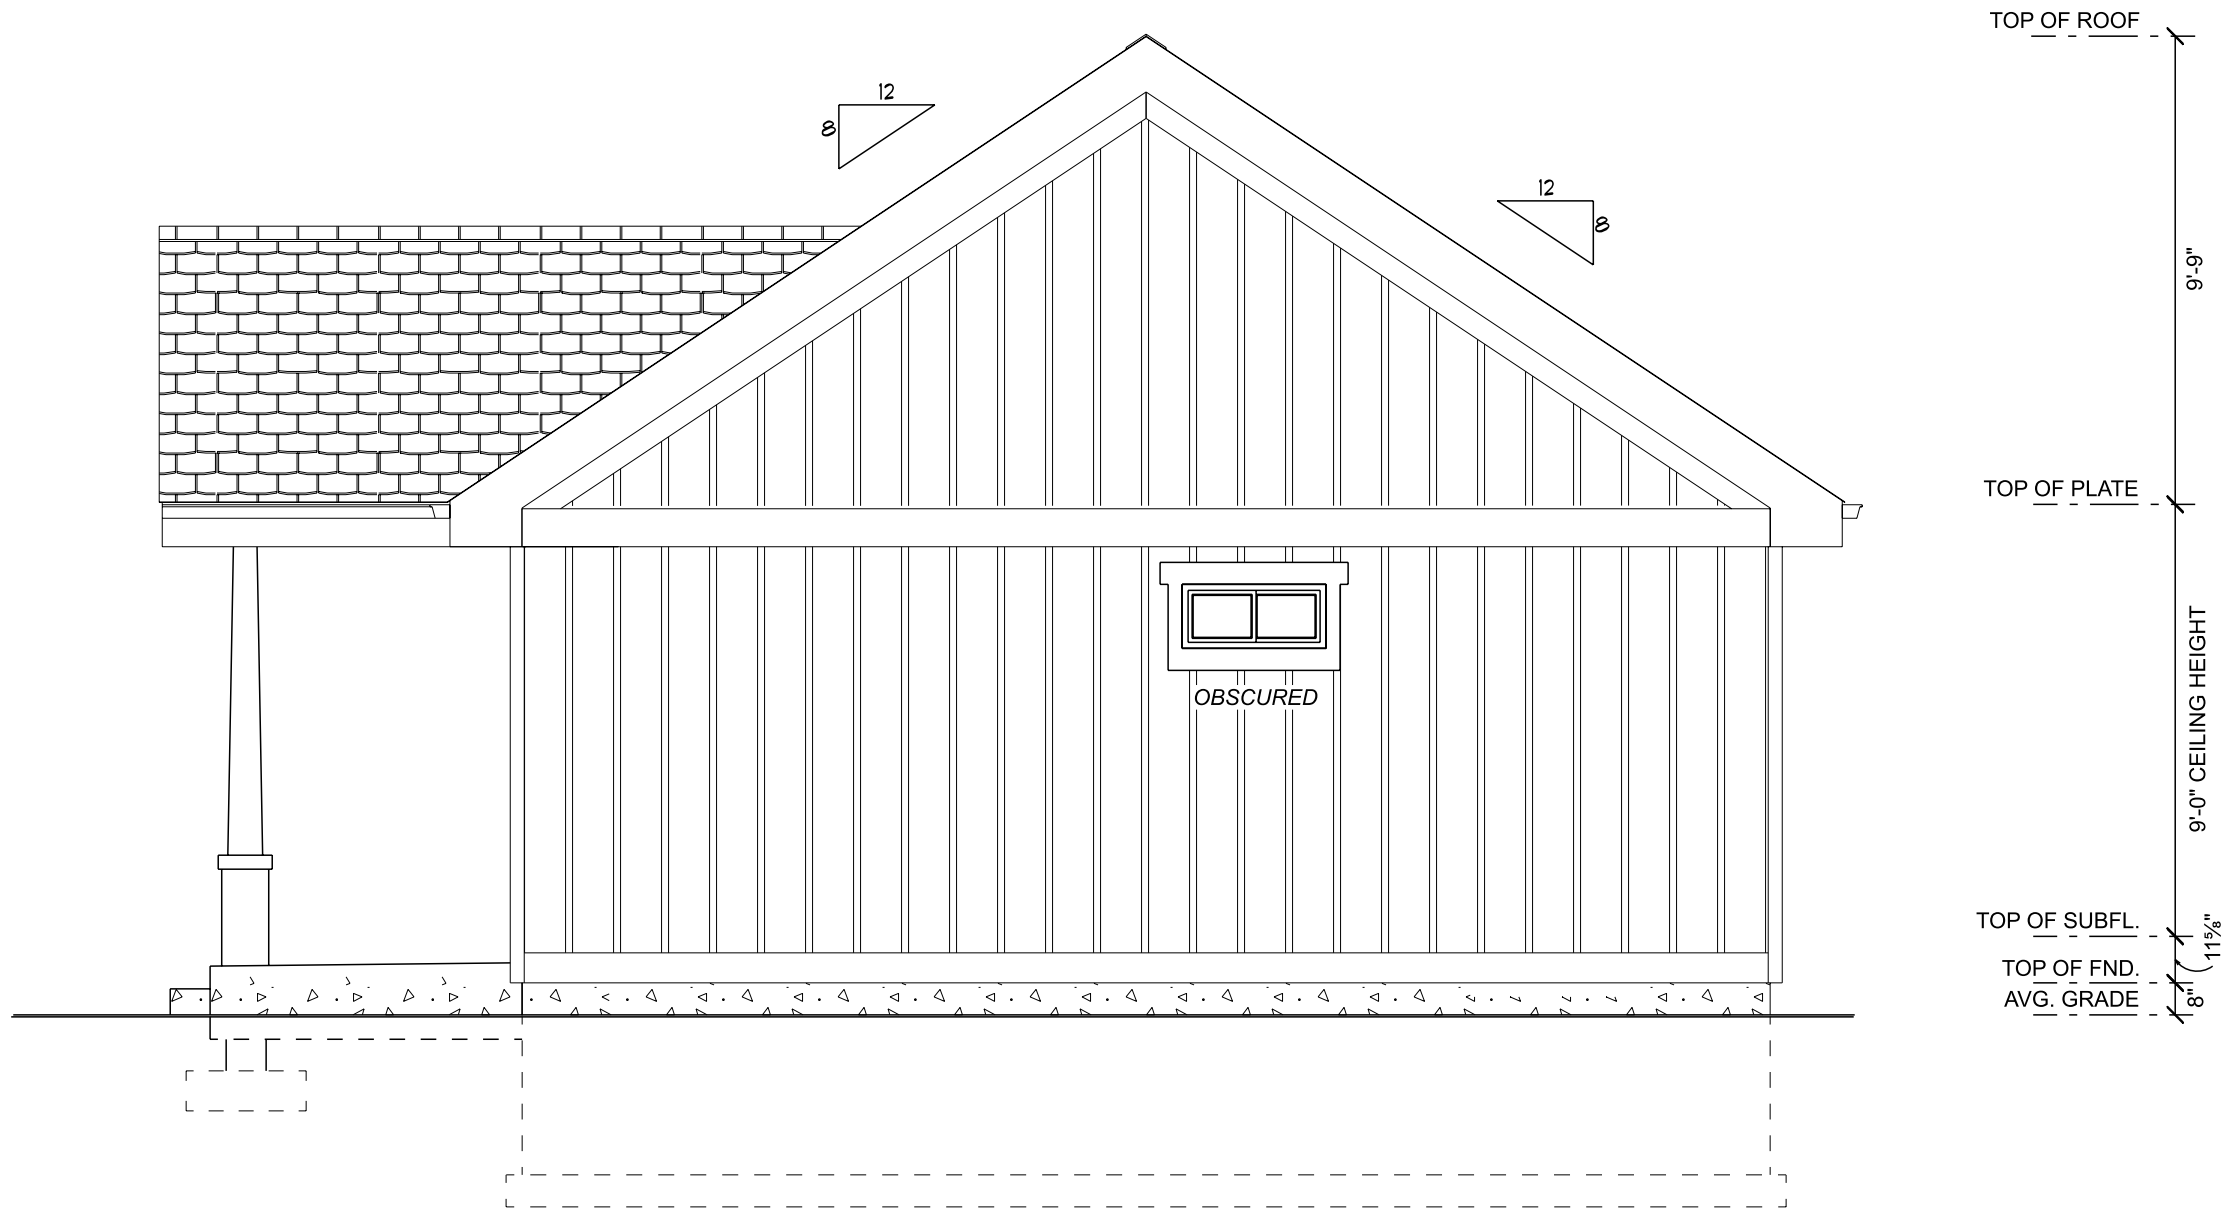

RIGHT ELEVATION

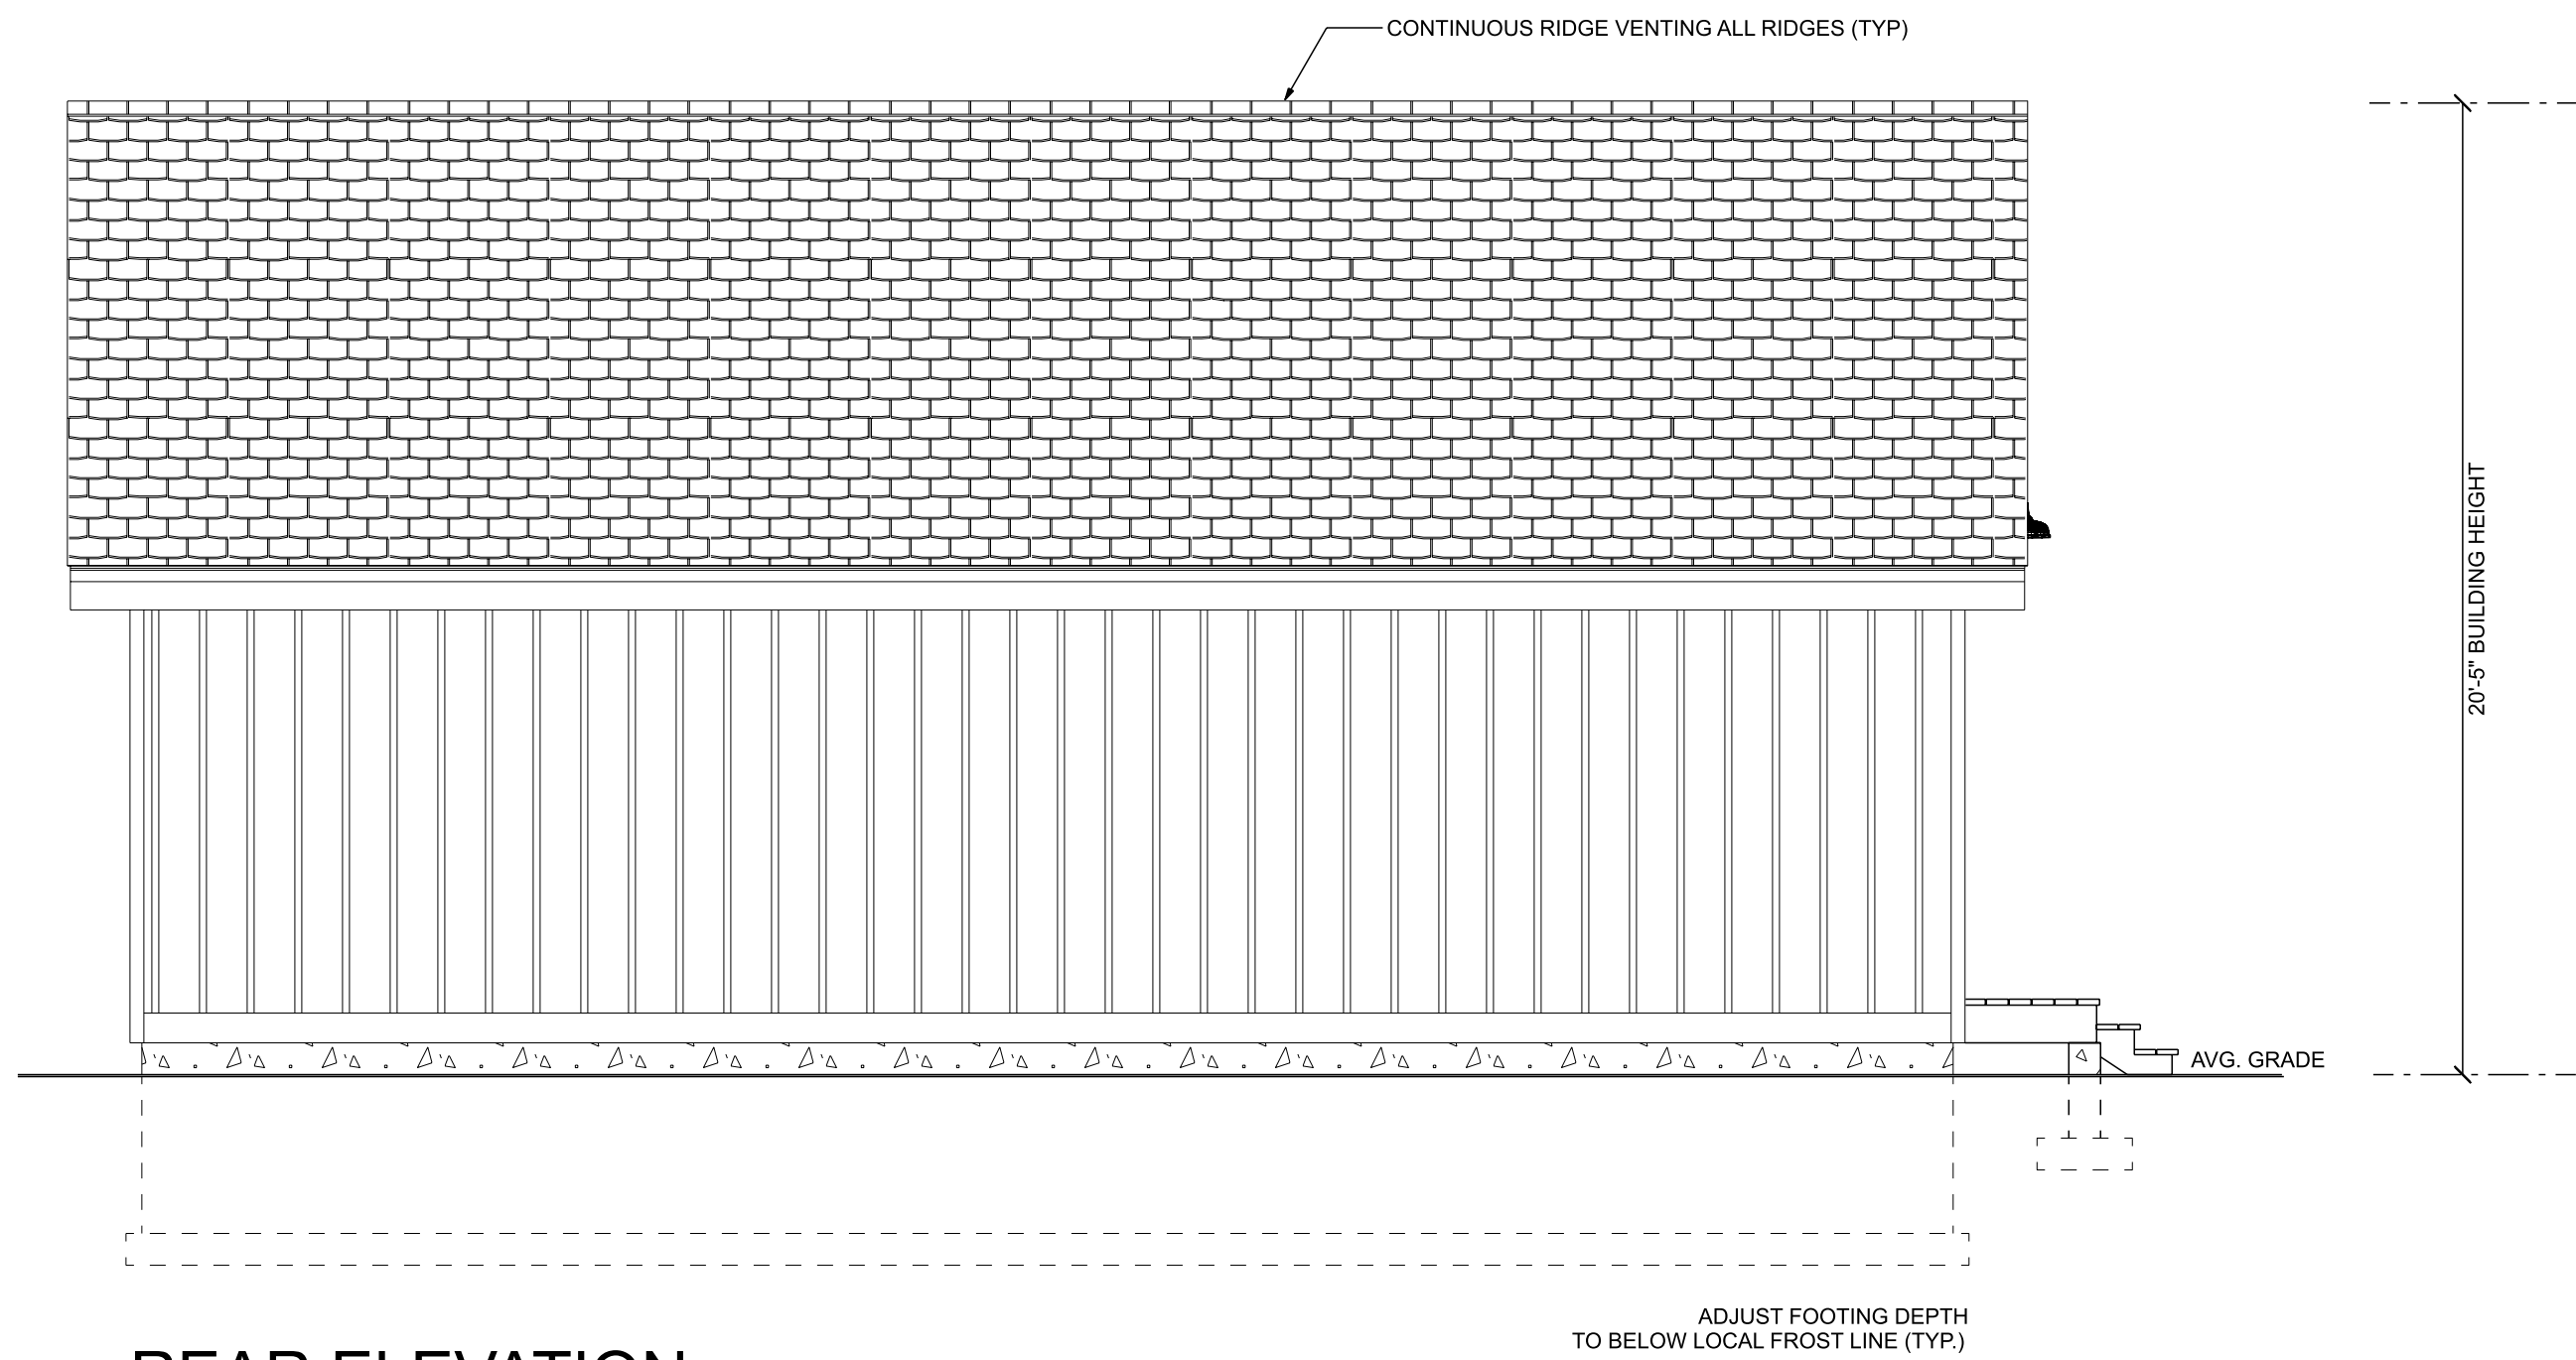

REAR ELEVATION

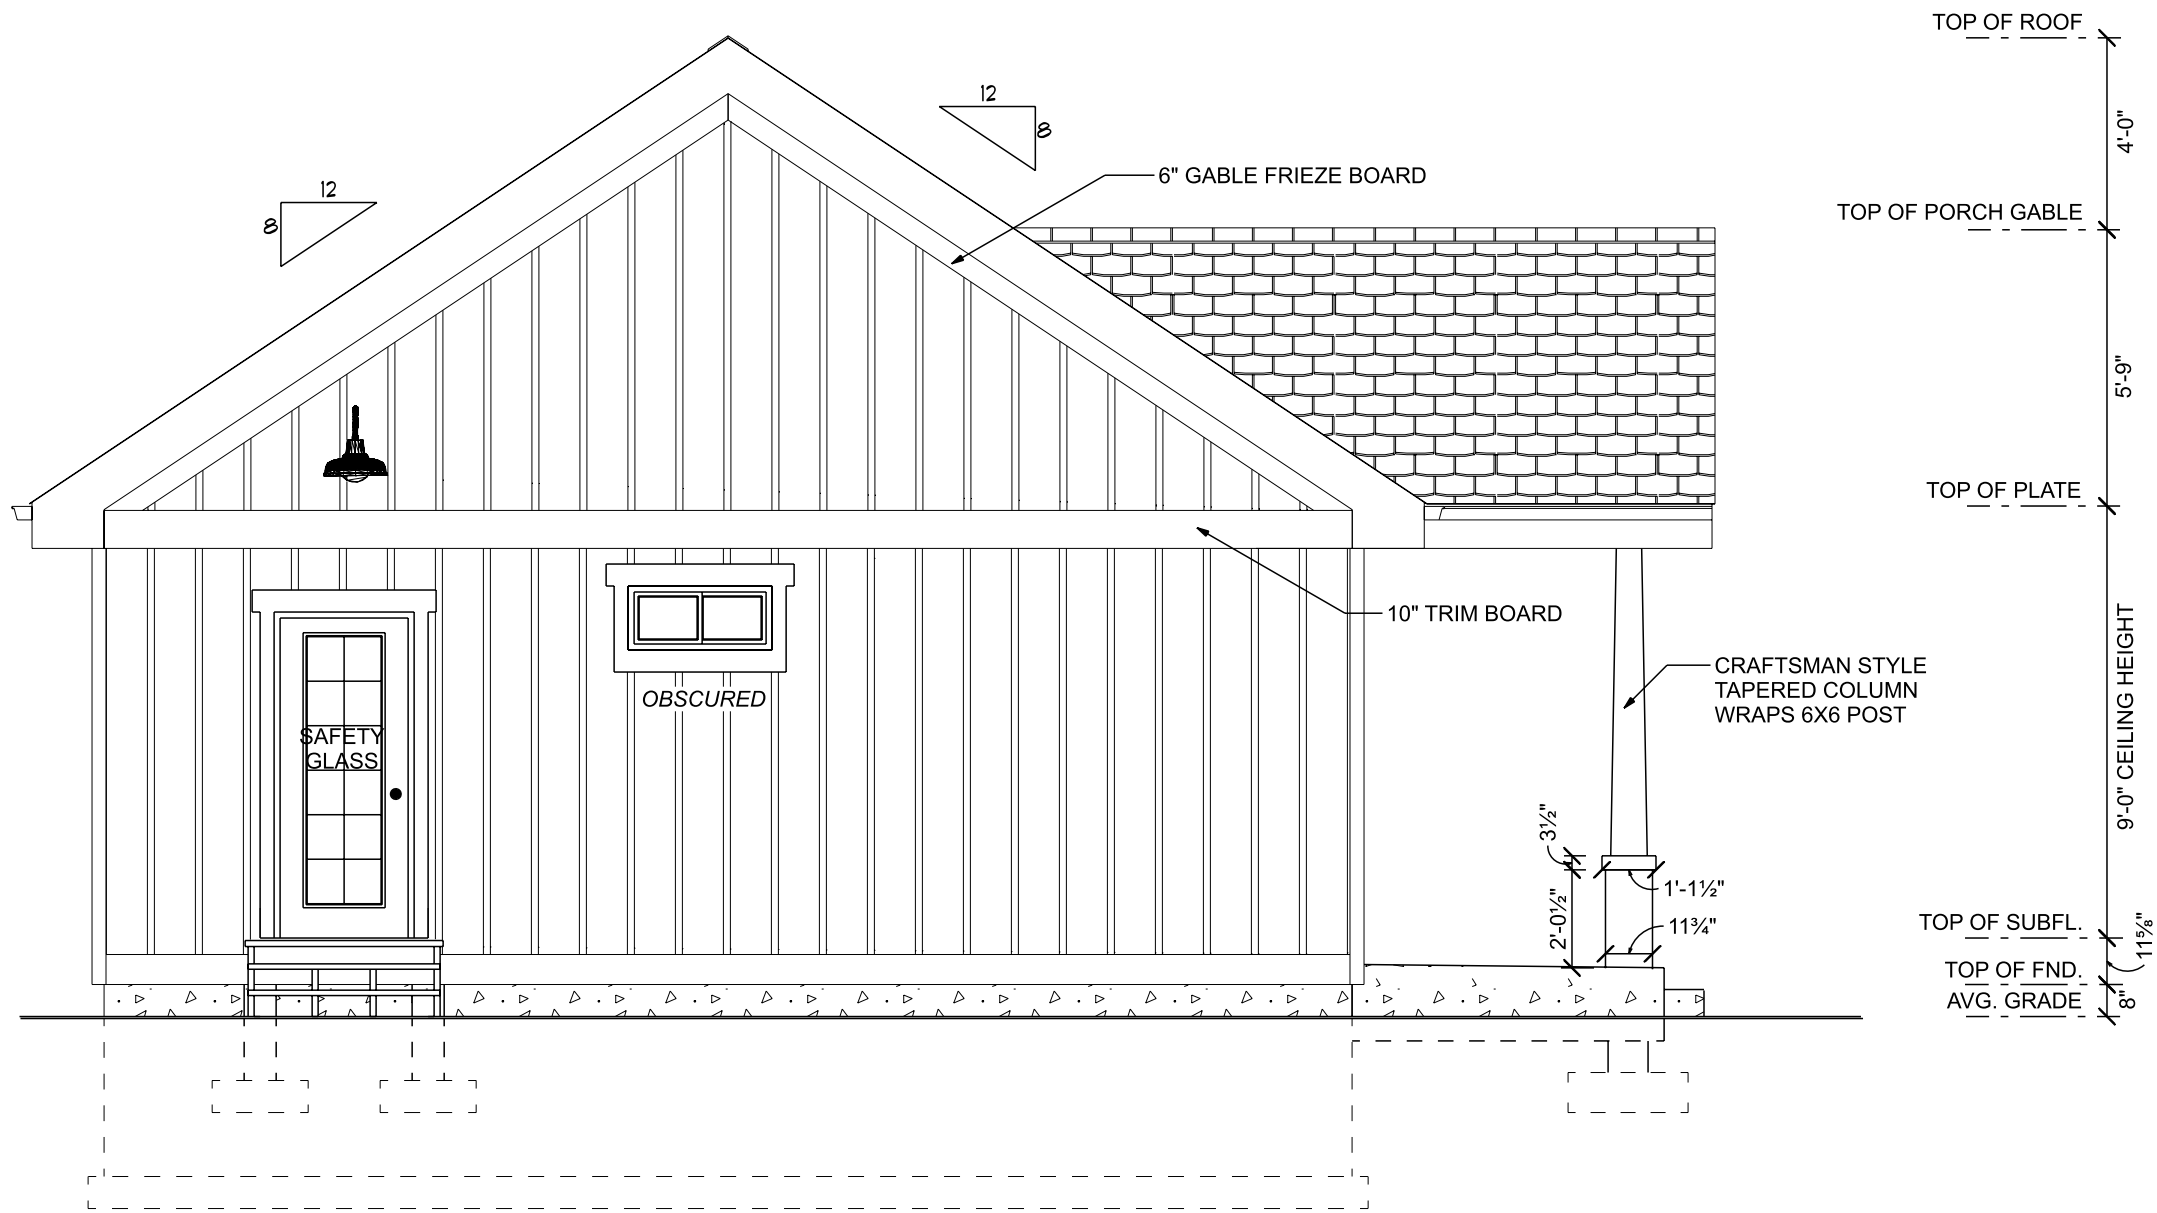

LEFT ELEVATION

**COPYRIGHTED DOCUMENTS
ILLEGAL TO REPRODUCE**


THESE PLANS ARE THE COPYRIGHTED PROPERTY
OF WESPLAN BUILDING DESIGN INC. AND HAVE
BEEN LICENSED TO THE ORIGINAL PURCHASER
FOR THE CONSTRUCTION OF ONE BUILDING.
IT IS UNLAWFUL TO REPRODUCE THESE
DOCUMENTS WITHOUT WRITTEN PERMISSION
IN THE FORM OF A LICENSE AGREEMENT.

DESIGN BY: ANMMAG | DATE: 1/16/2024
DRAWN BY: ANMMAG | REVISED:

© Wesplan Building Design Inc. All Rights Reserved
Reproduction of these drawings, in whole or in part, including any direct copying
and/or preparation of derivative works thereof, for any reason without prior written
permission of Wesplan Building Design Inc. is prohibited. These drawings are provided
to the buyer except for a limited license to use the drawings for the construction of
the building shown. These drawings are not to be used for any other purpose, and
at a reduced price from the original set or as part of a multiple set package does not
entitle the buyer with license to construct more than one dwelling unit.

Due to local codes, regulations and building practices and/or because of specific
site conditions, these drawings may not be suitable or legal for use in the
construction of a building in all localities. Consequently, these drawings are not to
be used for the construction of a building in any locality without the written
approval of Wesplan Building Design Inc. and until the drawings have been brought into conformity with all local
requirements. Additionally, Wesplan Building Design Inc. is unable to accept any
liability for damages or losses of any kind, including but not limited to, those
resulting from the use of these drawings. Therefore, the builder must carefully inspect all
dimensions and details in these drawings and assume responsibility for the same.

Wesplan Building Design Inc.
Your Number One Source for Home Plans Since 1950
Telephone: 800.361.7526
e-mail: am@westhomeplanners.com
web: www.westhomeplanners.com



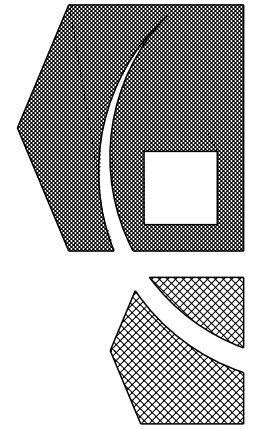


PLAN NO.
580988
CRAWLSPACE
SHEET NO.
A2


www.houseplanhunters.com

www.westhomeplanners.com

 
 
Exterior Elevations

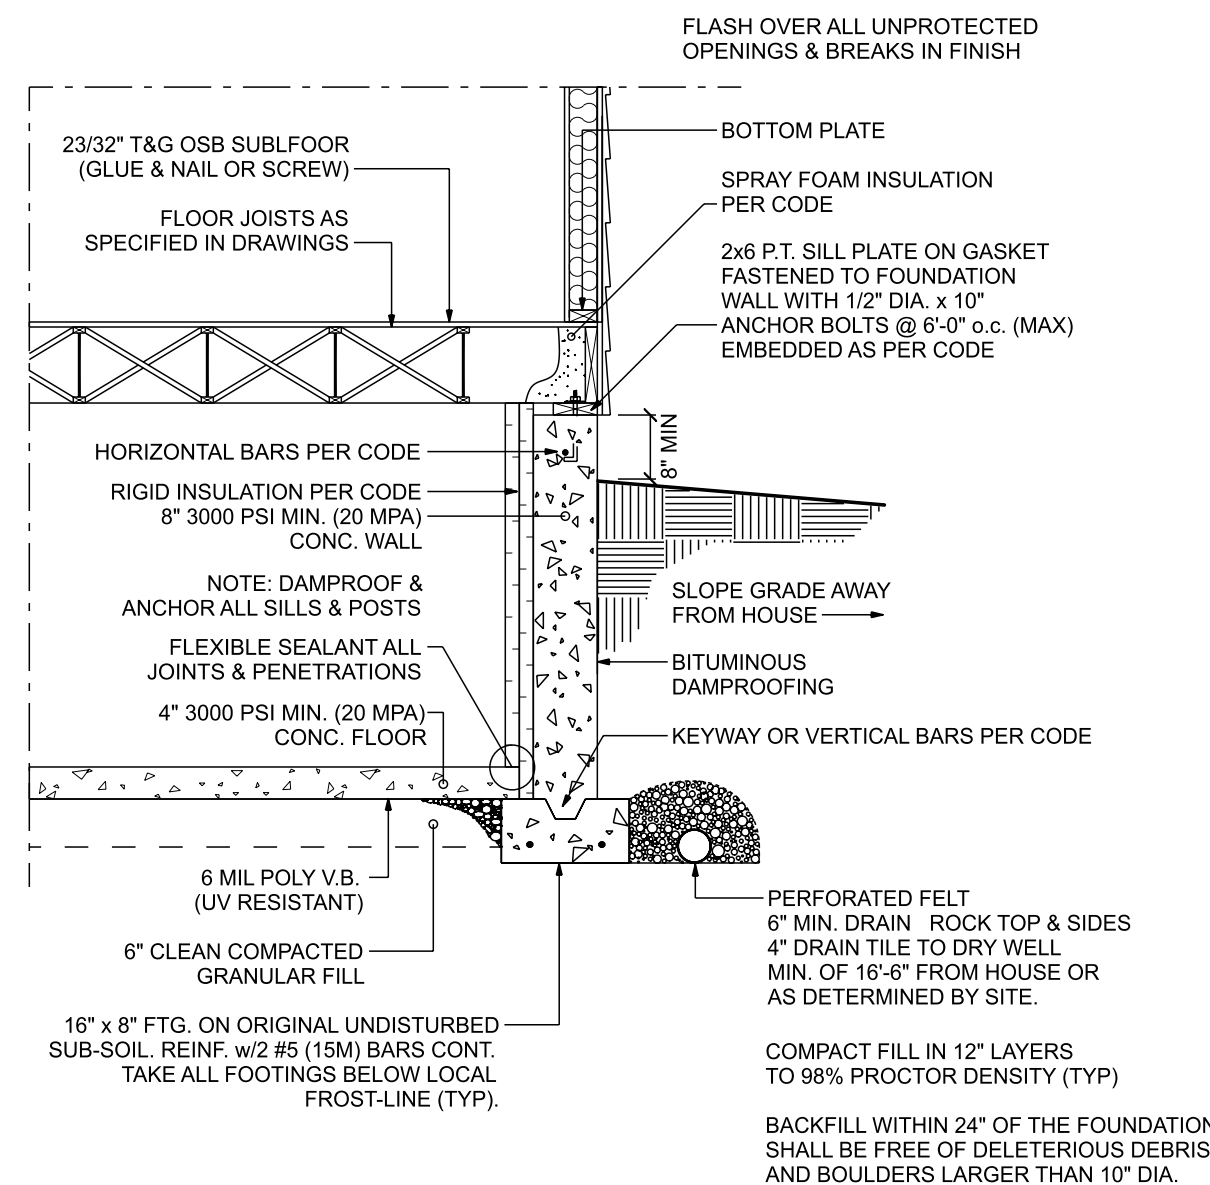


TYPICAL WALL SECTION
SCALE 1/2" = 1'-0"

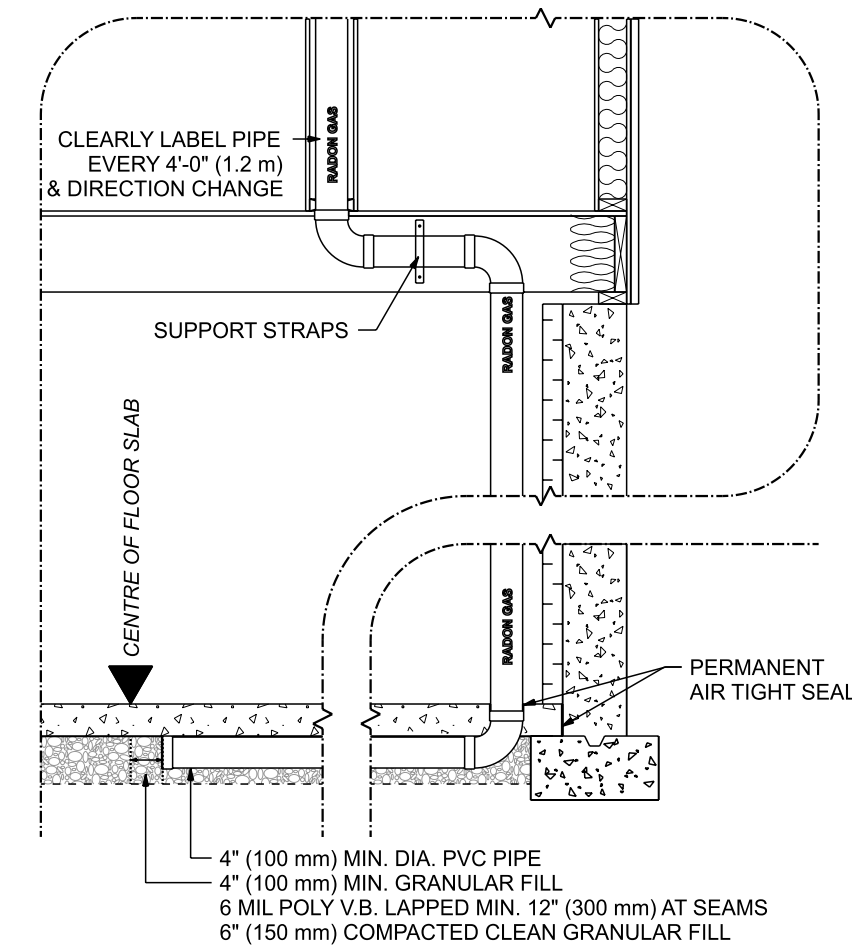

SOIL GAS DEPRESSURIZATION DETAIL

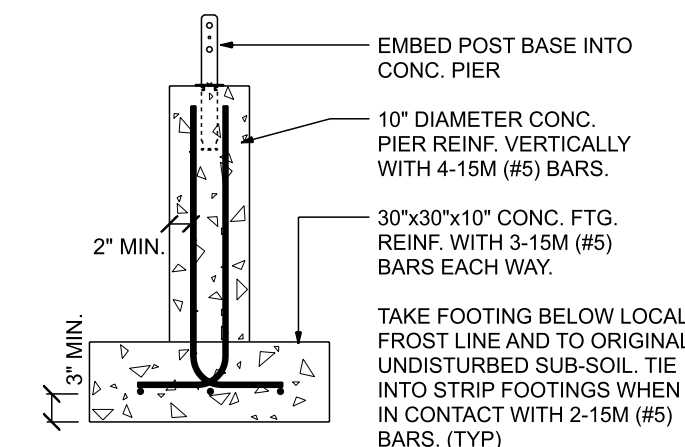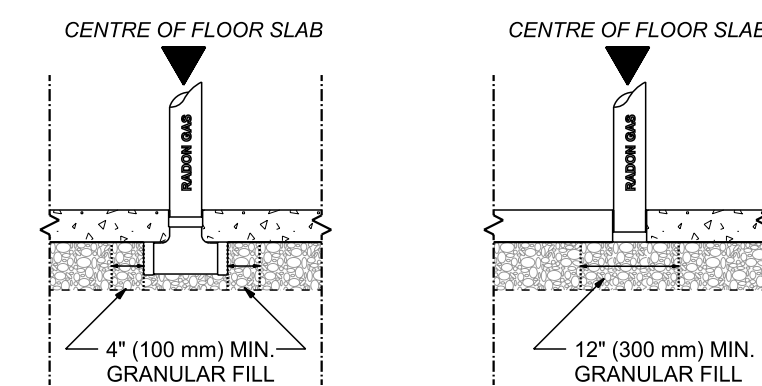


CONCRETE PIER & PAD DETAIL
SCALE 1/2" = 1'-0"

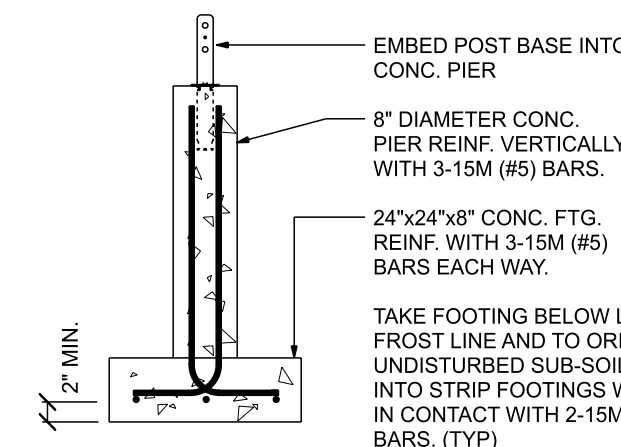

CONCRETE PIER & PAD DETAIL (SIDE STEPS)

SCALE 1/2" = 1'-0"

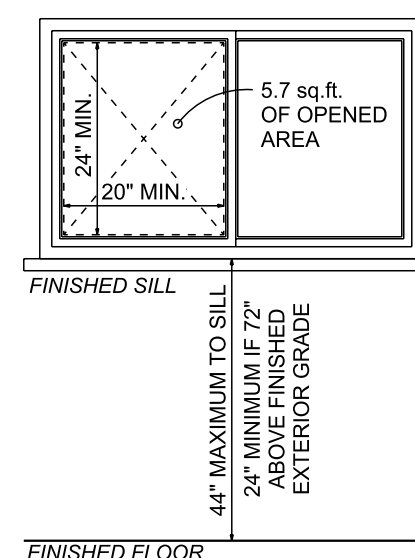

**EMERGENCY
EGRESS DETAIL**
SCALE: 1/2" = 1'-0"

EMERGENCY EGRESS WINDOWS
ONE REQUIRED IN EACH BEDROOM,
AT LEAST ONE TO SERVE THE
BASEMENT AND ONE IN EACH
BASEMENT BEDROOM.

WINDOW REQUIREMENTS:

1. 20" MIN. WIDTH (WHEN OPEN)
2. 24" MIN. HEIGHT (WHEN OPEN)
3. 5.7 sq.ft. NET CLEAR OPENING
EXCEPT ON GRADE FLOOR WHERE
5.0 sq.ft. IS REQUIRED
4. TOP OF FINISHED SILL SHOULD
BE A MAXIMUM OF 44" FROM TOP
OF FINISHED FLOOR
(IRC R310.1)

WINDOW WELL REQUIREMENTS:

1. WELL SHOULD HAVE A MINIMUM HORIZONTAL AREA OF 9.0 sq.ft.
2. WELL SHOULD HAVE A MINIMUM HORIZONTAL PROJECTION AND WIDTH OF 36 INCHES.
3. WINDOW WELLS WITH A VERTICAL DEPTH OF GREATER THAN 44 INCHES SHALL BE EQUIPPED WITH A PERMANENT AFFIXED LADDER OR STEPS USABLE WITH THE WINDOW IN A FULLY OPEN POSITION (IRC R310.2)

**COPYRIGHTED DOCUMENTS
ILLEGAL TO REPRODUCE**

THESE PLANS ARE THE COPYRIGHTED PROPERTY
OF WESPLAN BUILDING DESIGN INC. AND HAVE
BEEN LICENSED TO THE ORIGINAL PURCHASER
FOR THE CONSTRUCTION OF ONE BUILDING.
IT IS UNLAWFUL TO REPRODUCE THESE
DOCUMENTS WITHOUT WRITTEN PERMISSION
IN THE FORM OF A LICENSE AGREEMENT.

Wesplan Building Design Inc.
Your Number One Source for Home Plans Since 1950
 Telephone: 800.361.7526
 e-mail: ammi@westhomeplanners.com
 web: www.westhomeplanners.com

PLAN NO. 580988 CRAWLSPACE	SHEET NO. A4
--	-----------------------------------

© Wesplan Building Design Inc. MMXX All Rights Reserved


Due to local codes, regulations and building practices and/or because of specific site conditions, these drawings may not be suitable or legal for use in the construction of a building in all localities. Consequently, these drawings are not to be used as a guide for construction unless the builder has confirmed their suitability and until the drawings have been brought into conformity with all local requirements. Additionally, Wespian Building Design Inc. is unable to accept any liability for the accuracy or overall integrity of these drawings in excess of their original purchase price. Therefore, the builder must carefully inspect all dimensions and details in these drawings and assume responsibility for the same.

DESIGN BY: AMM/MAG	DATE: 1/16/2024
DRAWN BY: AMM/MAG	REVISED:

www.houseplanhunters.com

www.westhomeplanners.com

 Cross Sections & Details



ELECTRICAL LEGEND

ELECTRICAL NOTE:
CONFIRM ALL ELECTRICAL FIXTURE PLACEMENTS AND QUANTITIES WITH HOME OWNER AND BUILDER BEFORE ORDERING. OUTLET LOCATIONS ON PLANS COMPLY WITH MINIMUM BUILDING CODE REQUIREMENTS AND ARE TO BE USED AS A GUIDE ONLY. ADJUST TO MEET OWNER'S AND/OR LOCAL AUTHORITIES REQUIREMENTS. HARDWARE INTERCONNECTED SMOKE & CARBON MONOXIDE DETECTORS AND ALARMS, PROVIDE BATTERY BACKUP FOR ALL UNITS. ALL ELECTRICAL FIXTURES AND ITEMS MUST COMPLY WITH LOCAL ELECTRICAL CODES AND REGULATIONS.

**COPYRIGHTED DOCUMENTS
ILLEGAL TO REPRODUCE**

THESE PLANS ARE THE COPYRIGHTED PROPERTY
OF WESPLAN BUILDING DESIGN INC. AND HAVE
BEEN LICENSED TO THE ORIGINAL PURCHASER
FOR THE CONSTRUCTION OF ONE BUILDING.

IT IS UNLAWFUL TO REPRODUCE THESE
DOCUMENTS WITHOUT WRITTEN PERMISSION
IN THE FORM OF A LICENSE AGREEMENT.